




2
2

REFLECTED CEILING PLAN

1
2

FLOOR PLAN

SCALE 1/4" = 1'-0"

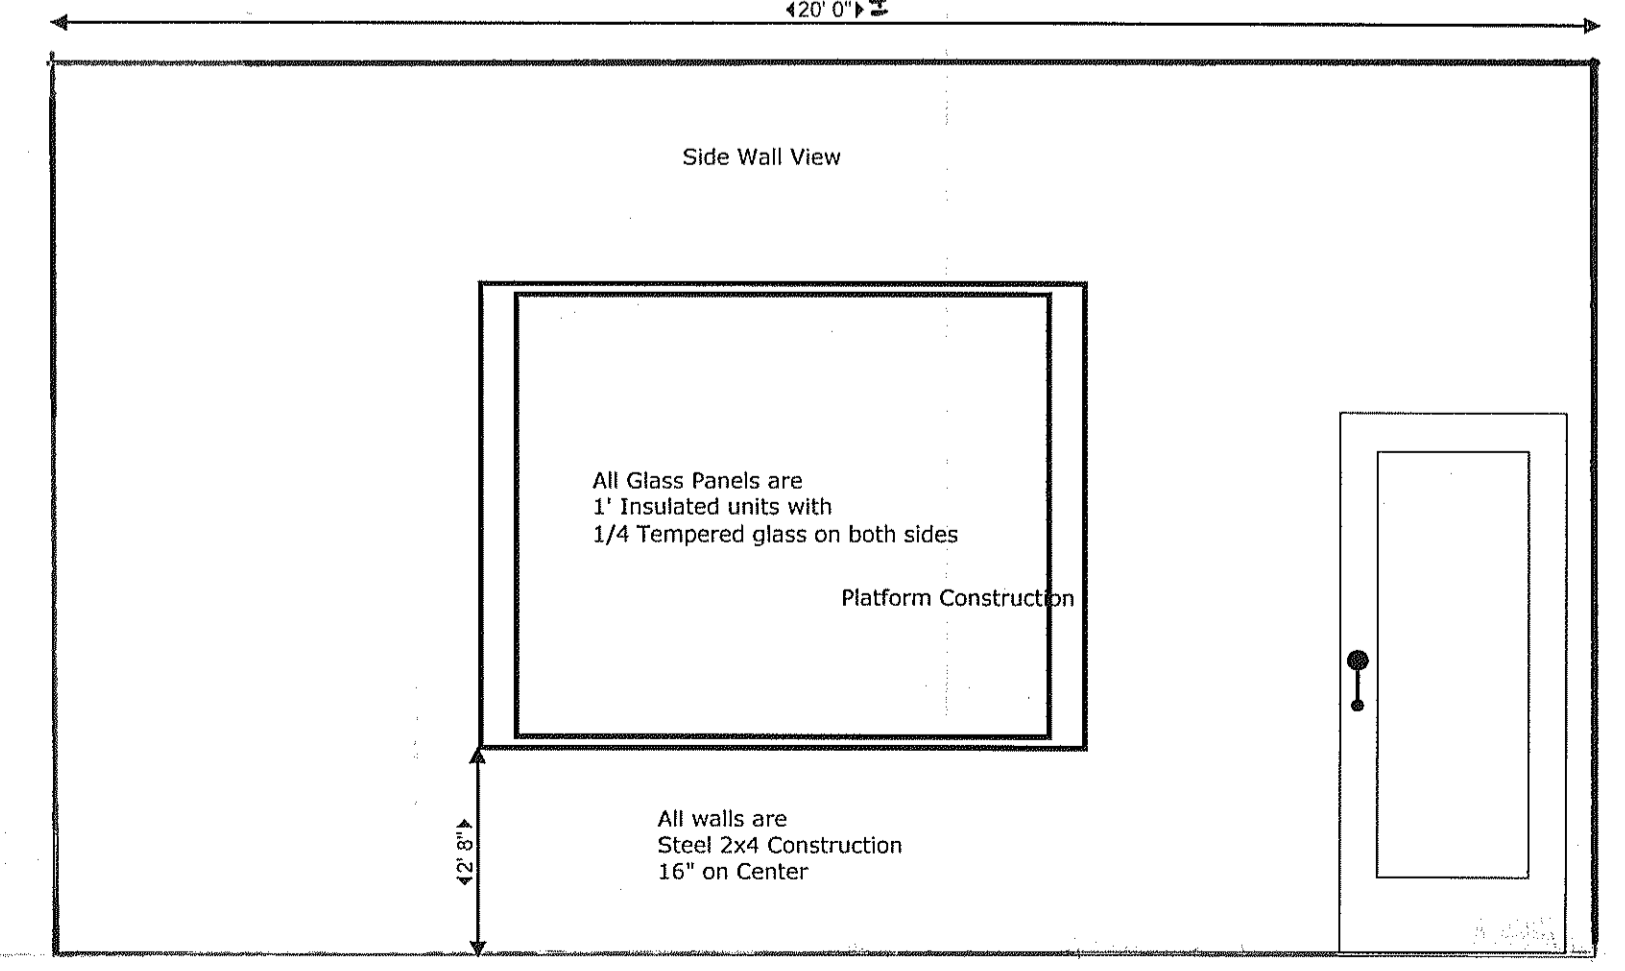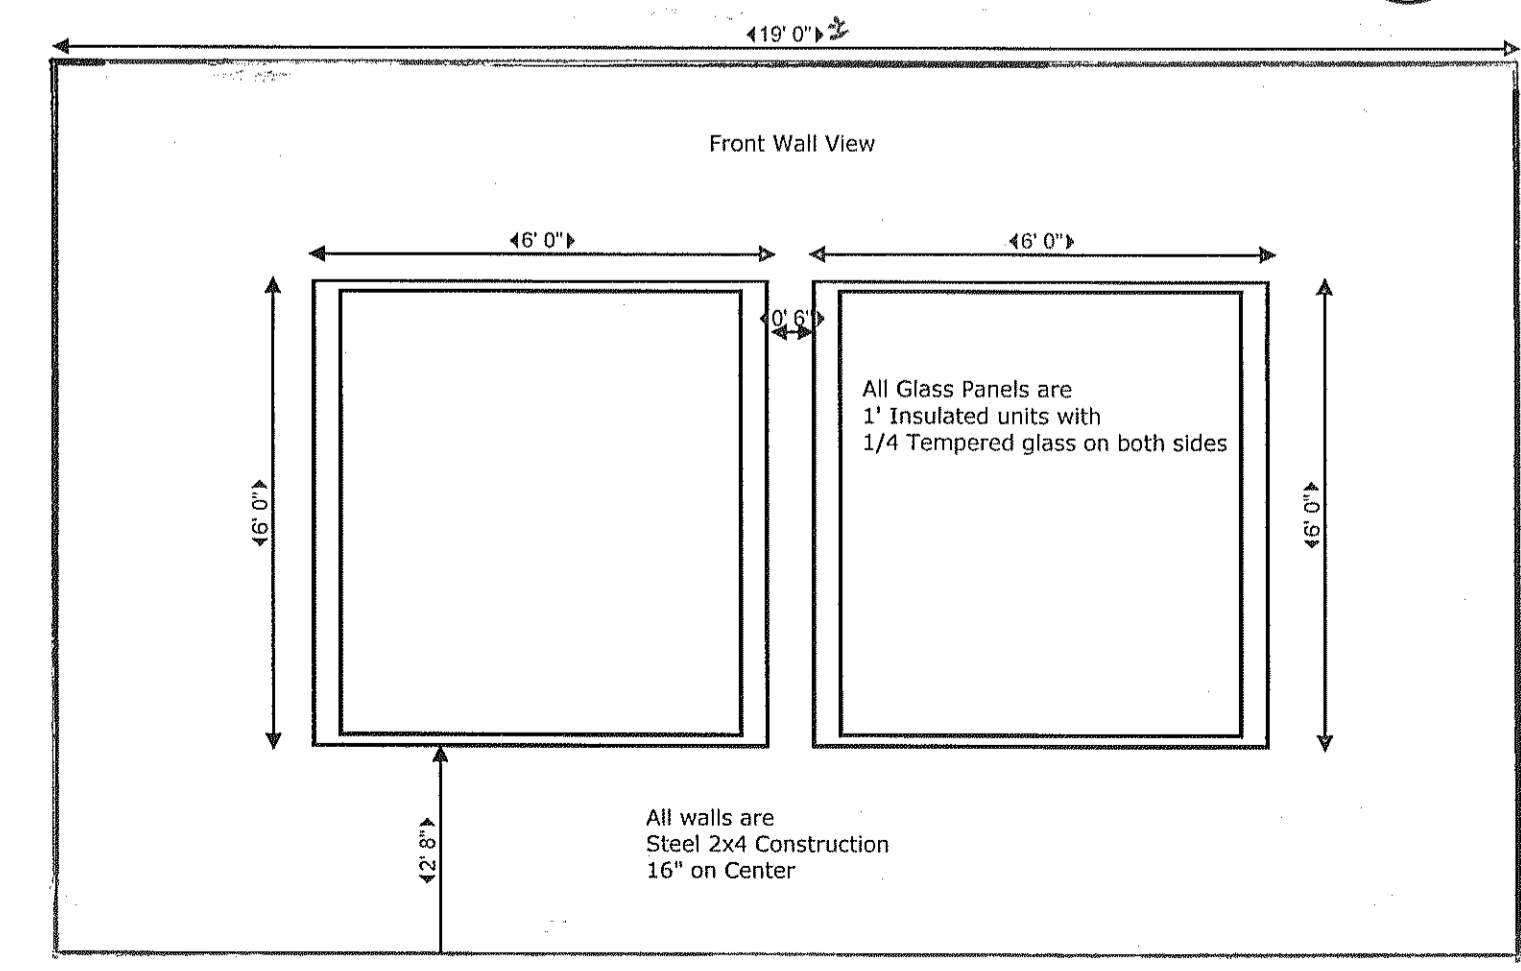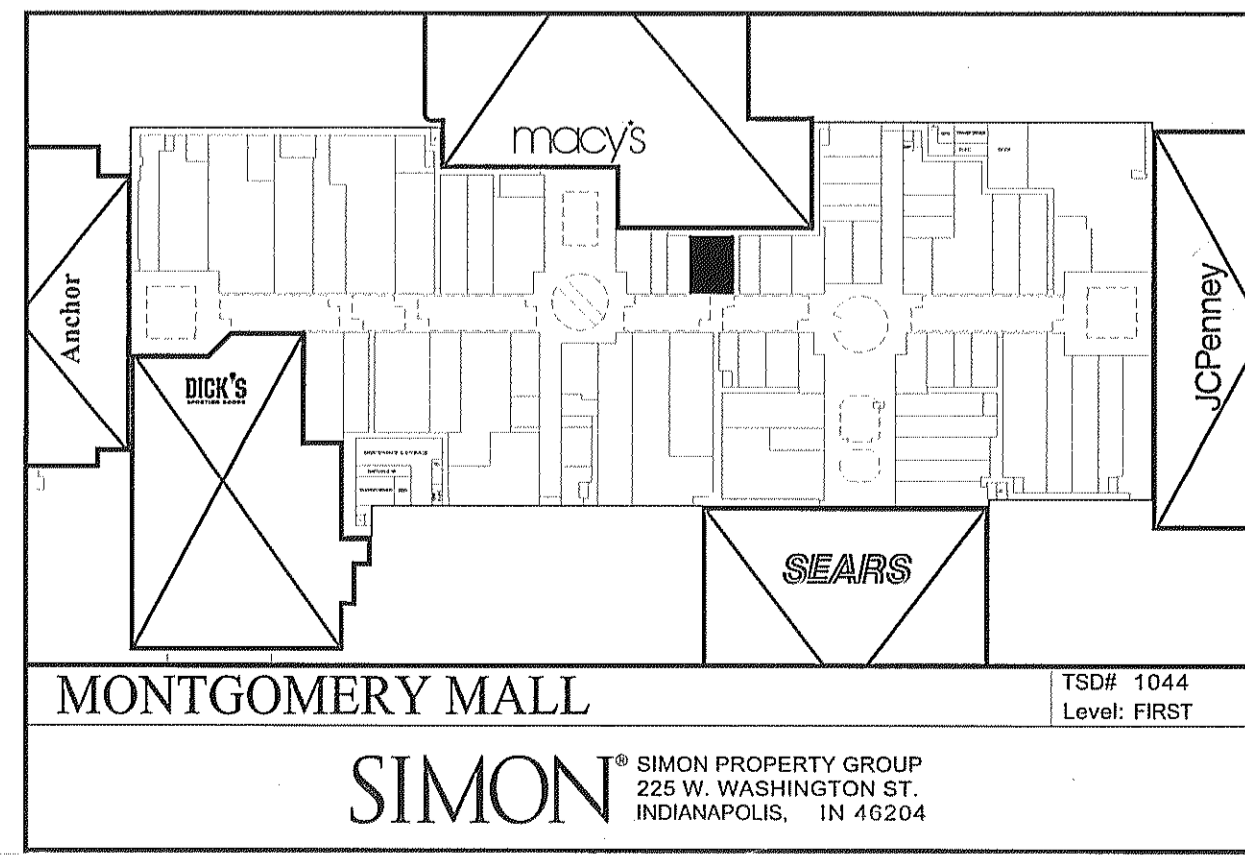

PROPOSED ALTERATIONS

| REV. # | REVISION DESCRIPTION | DATE |
|------------|----------------------|------|
| 06-13-2011 | | |
| 06-21-2011 | | |

NOT VALID FOR PERMITS UNLESS AFFIXED WITH EMBOSSED SEAL & ORIGINAL SIGNATURE IN RED.

Eric C. Van Rensd. Architect
Creative Design Associates, Inc.
 ARCHITECTURE INTERIORS SITE & SPACE PLANNING
 350 Callowhill Road
 Chalfont, PA 18914
 Voice: 215-672-1155
 www.ArchitectVision.com

PROPOSED ALTERATIONS
 Montgomeryville Mall: Unit 1044
 TENANT FIT-OUT
MALLSTARS, LLC
 MONTGOMERY TWP., MONTGOMERY CO., PA